

DO NOT SCALE

26/09/2018 09:17:21

RCA Document Reference: RCA A1 Landscape Version 1


R:\RCA Job Files\19526\19526 - International Coastal Centre Saundersfoot\19526-03.dwg  
Drawing: 19526-03.dwg  
RCA Job File: 19526 - International Coastal Centre Saundersfoot\19526-03.dwg  
Drawing: 19526-03.dwg  
RCA Job File: 19526 - International Coastal Centre Saundersfoot\19526-03.dwg  
Drawing: 19526-03.dwg

Existing Harbour  
Master's Office

MILFORD  
STREET

BREWERY TERRACE

CAMBRIAN TERRACE

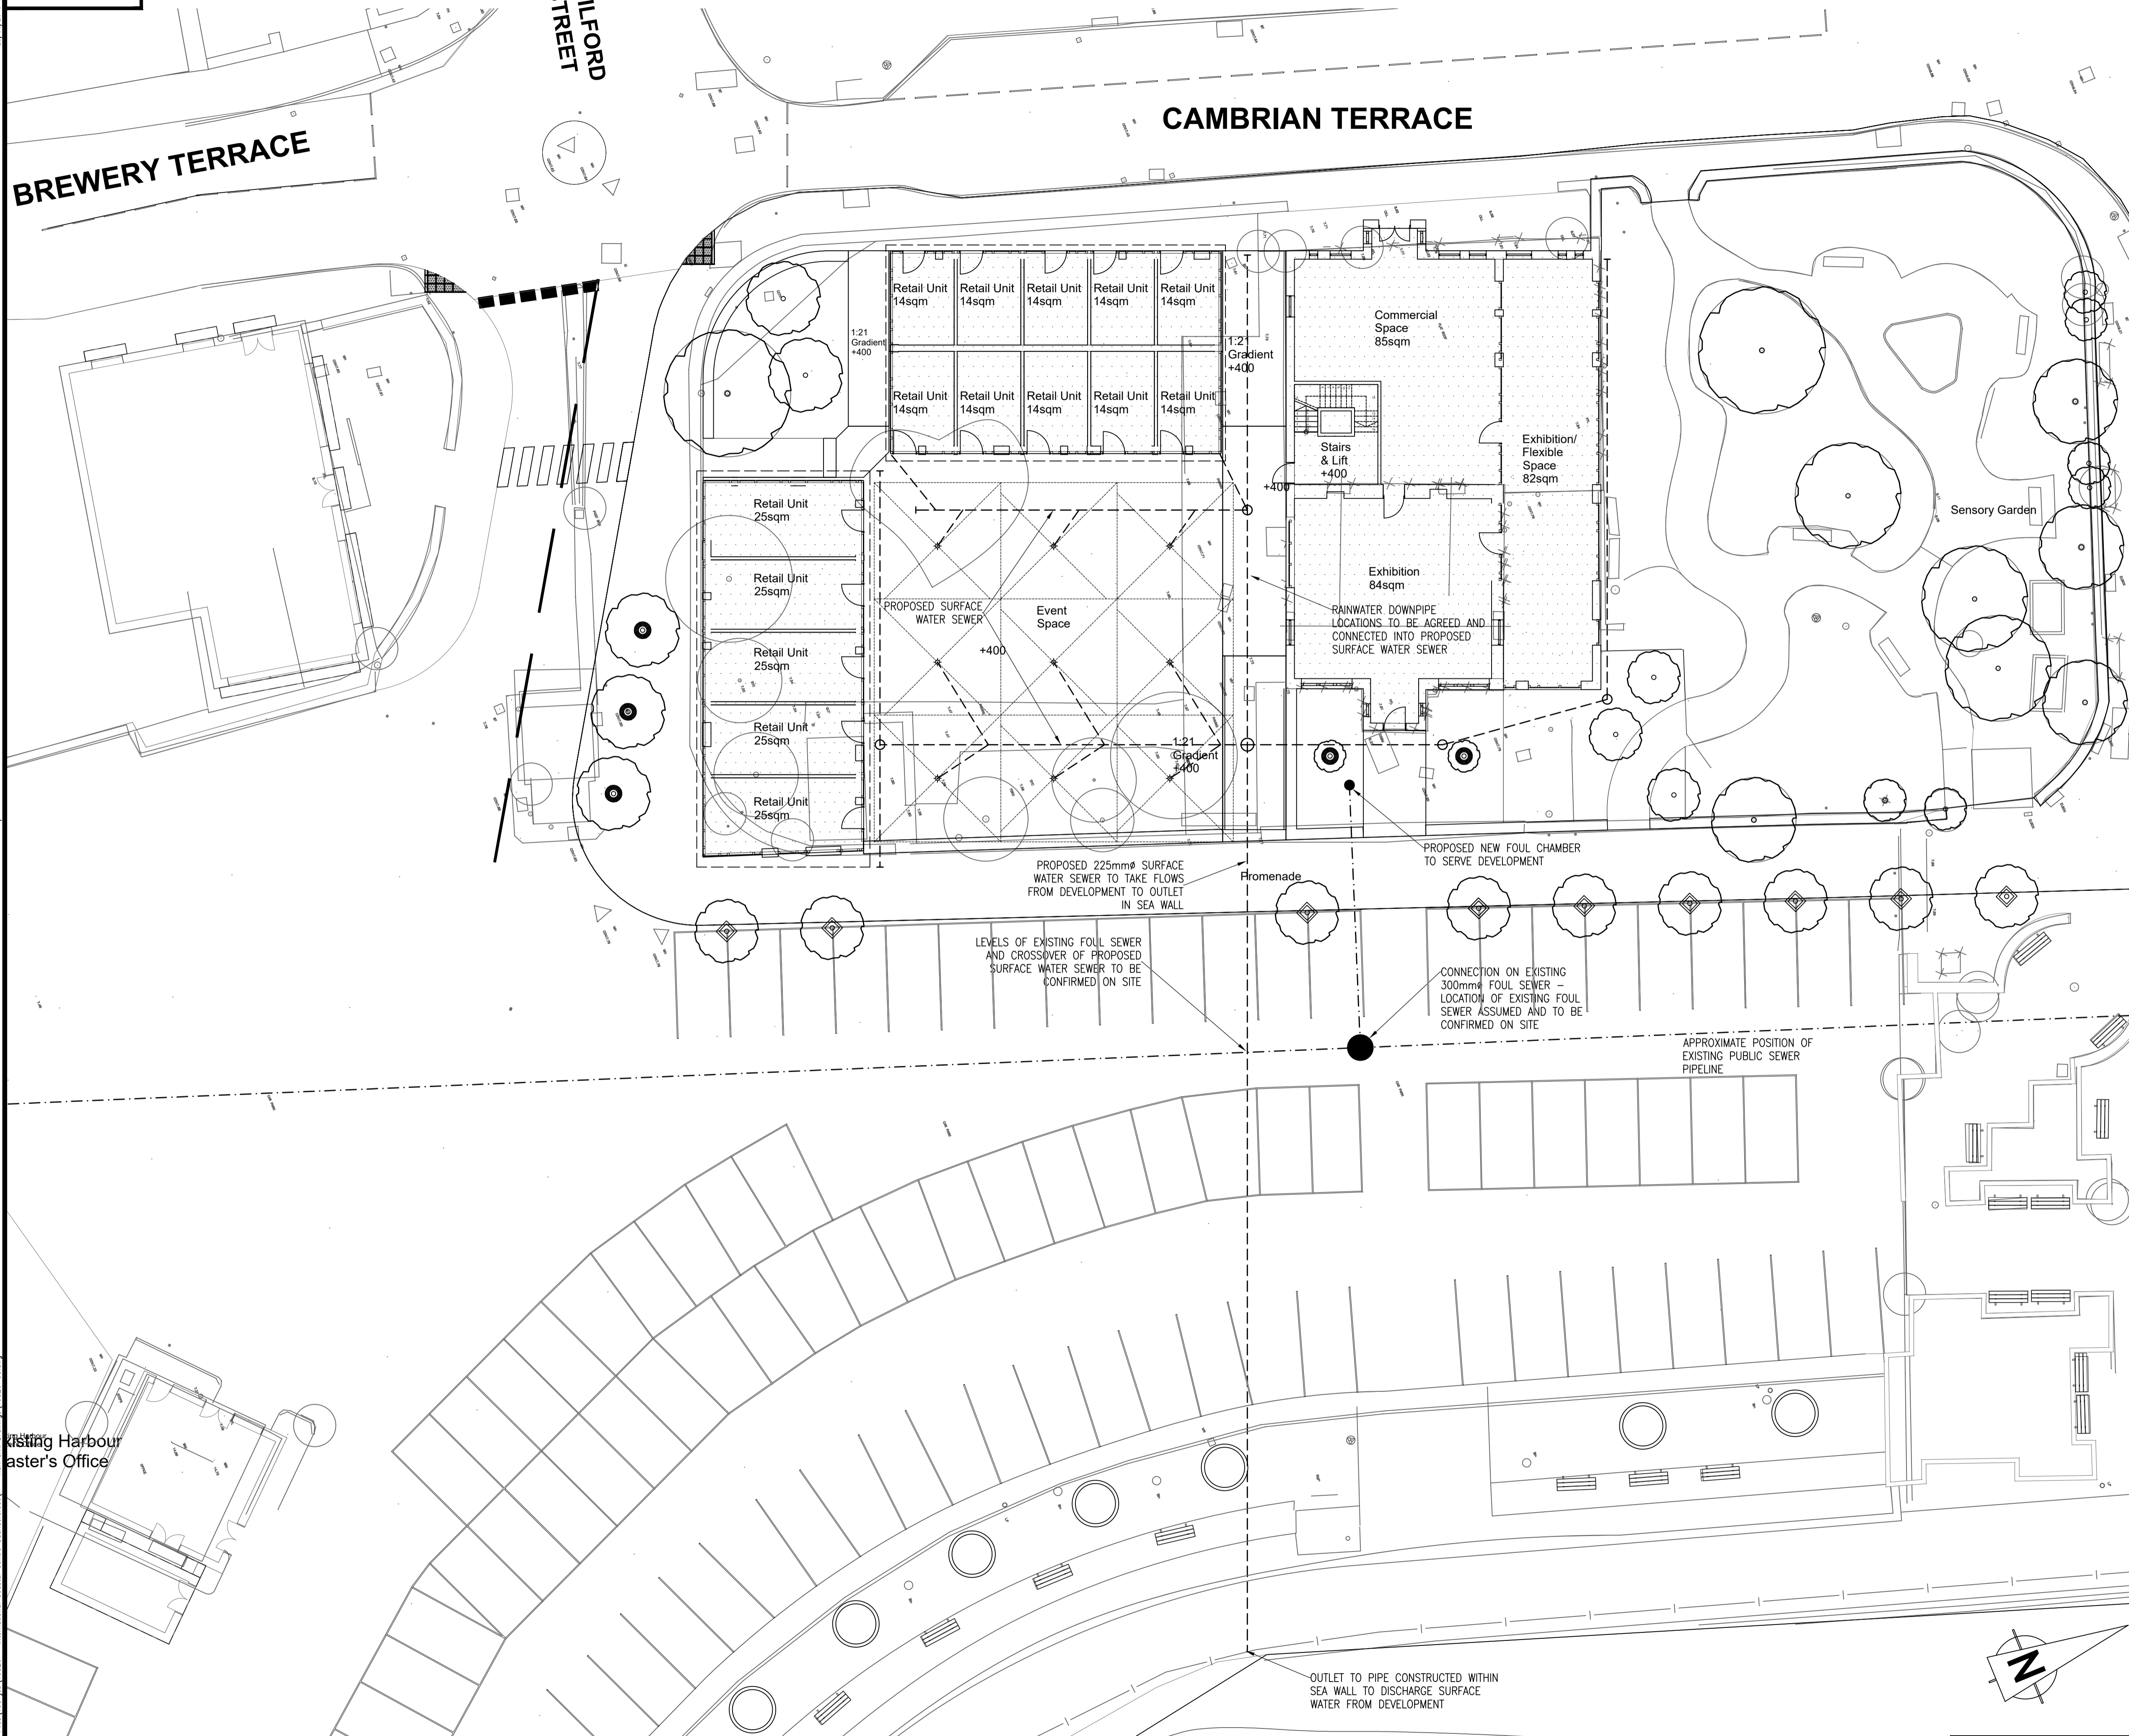

NOTES:

THE PROPERTY OF THIS DRAWING AND DESIGN IS VESTED IN ROGER CASEY ASSOCIATES AND MUST NOT BE COPIED OR REPRODUCED IN ANY WAY WITHOUT THE WRITTEN CONSENT OF ROGER CASEY ASSOCIATES.

THE CONTRACTOR IS TO CHECK ALL LEVELS AND DIMENSIONS BEFORE WORK COMMENCES, AND ANY DISCREPANCIES TO BE REPORTED IMMEDIATELY TO THE CONSULTANTS.

WORK TO FIGURED DIMENSIONS IN PREFERENCE TO SCALING.

THIS DRAWING IS TO BE READ IN CONJUNCTION WITH ALL OTHER ROGER CASEY ASSOCIATES DRAWINGS AND SPECIFICATIONS AND ALL OTHER CONSULTANTS DRAWINGS AND SPECIFICATIONS RELATING TO THIS PROJECT.

KEY

FOUL WATER DRAINAGE — F1 —

SURFACE WATER DRAINAGE — S1 —

REV	DESCRIPTION	DATE
A	ADDITIONAL NOTES ADDED	23/05/18

DRAWING STATUS:  
**PLANNING**

**Roger Casey Associates**  
Consulting Civil & Structural Engineers

Ty Mansel, 6 Mansel Street,  
Carmarthen,  
Carmarthenshire SA31 1PX

T: 01267 222 646

Units 10 & 11, Merlin's Court,  
Winch Lane, Haverfordwest,  
Pembrokeshire SA61 1SB

T: 01437 762 795

E: office@rca-eng.co.uk

W: www.rca-eng.co.uk

CLIENT:  
**WALES INTERNATIONAL  
COASTAL CENTRE**

ARCHITECT:  
**powelldobson**

PROJECT:  
**OCEAN SQUARE, SAUNDERSFOOT  
HARBOUR REGENERATION,  
SAUNDERSFOOT, PEMBS**

DRAWING TITLE:  
**PROPOSED DRAINAGE SITE PLAN**

DRAWN BY:	DESIGN BY:	CHECKED BY:	DATE:
GWP	GWP	PWJL	23/05/18
SCALES:	DRAWING No.:	REVISION:	
1:150	19526/03	A	

ORIGINAL DRAWING A1  
© Roger Casey Associates Limited 2018